


X65
SPEED SENSOR
JST
3WAY PM
PN: 03T-JWPF-VSLE-S




X66
2D SPEED SENSOR
DEUTCH 3 WAY PF
PN: ASI 07-98SN

NOTES: ELECTRICAL DIAGRAM

		MecTronik s.r.l. automotive electronic applied	
SIZE B	CAGE CODE	DWG NO. CBL0009	REV 1
SCALE 1:1		SHEET 2 of 2	

DOCUMENTO INFORMATIVO: IL PRESENTE DOCUMENTO È LA COPIA DELLA DISTRIBUZIONE, E L'UTILIZZO SENZA IL PREVO CONSENSO SCRITTO, INOLTRE MESSURA DANNO DIRETTO O INDIRETTO PIU' ATTRIBUISI A MECTRONIK S.R.L. PER EVENTUALI IMPRESSIONI O ERRORI CONTENUTI NEL DOCUMENTO.

AS1 07-98SN

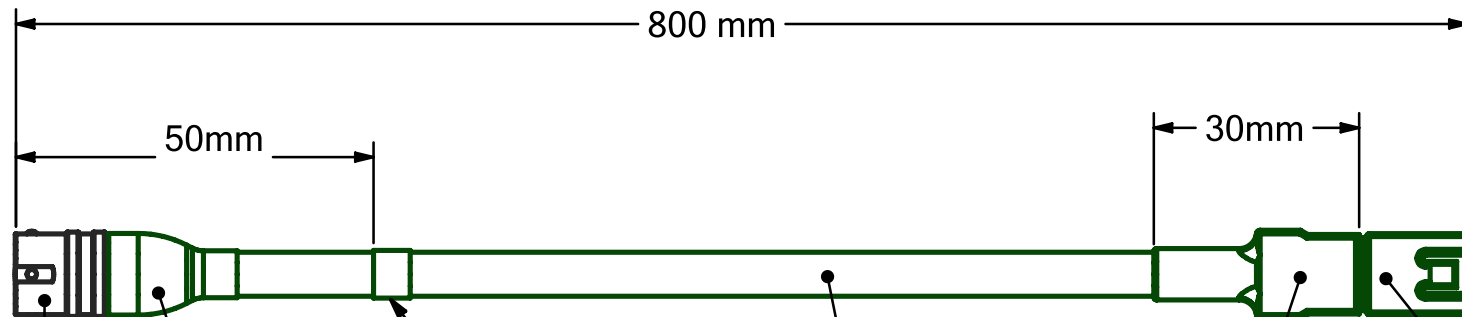

HEAT SHRINK BOOT

DR25 HEAT SHRINK

HT AT SLEEVE

03T-JWPF-VSLE

PN. LABEL
MecTronik CBL0009
Vers.1.0 + DATE

NOTES: REFER TO B-127-E-130421-0300_KALEX-765_CEV2022 DRAW FOR ELECTRICAL DETAILS

REVISION HISTORY

DESCRIPTION

CHECKED

INCORP BY

DATE

REV

THIRD ANGLE PROJECTION 	PRODUCT CODE		MATERIAL	INIT	APPROVALS	DATE	INIT	APPROVALS	DATE	MecTronik s.r.l. automotive electronic applied
			FINISH		Claudio				10/14/2021 1:00:49 PM	
			TREATMENT							TITLE
			SIMILAR TO							WIRING BRIDGE FOR MOTO2 SPEED SENSOR
	NEXT ASSY	USED ON								SIZE B
	APPLICATION									CAGE CODE
										DWG NO.
										CBL0009
										REV 1
										SCALE 1:1
										SHEET 1 of 2

